

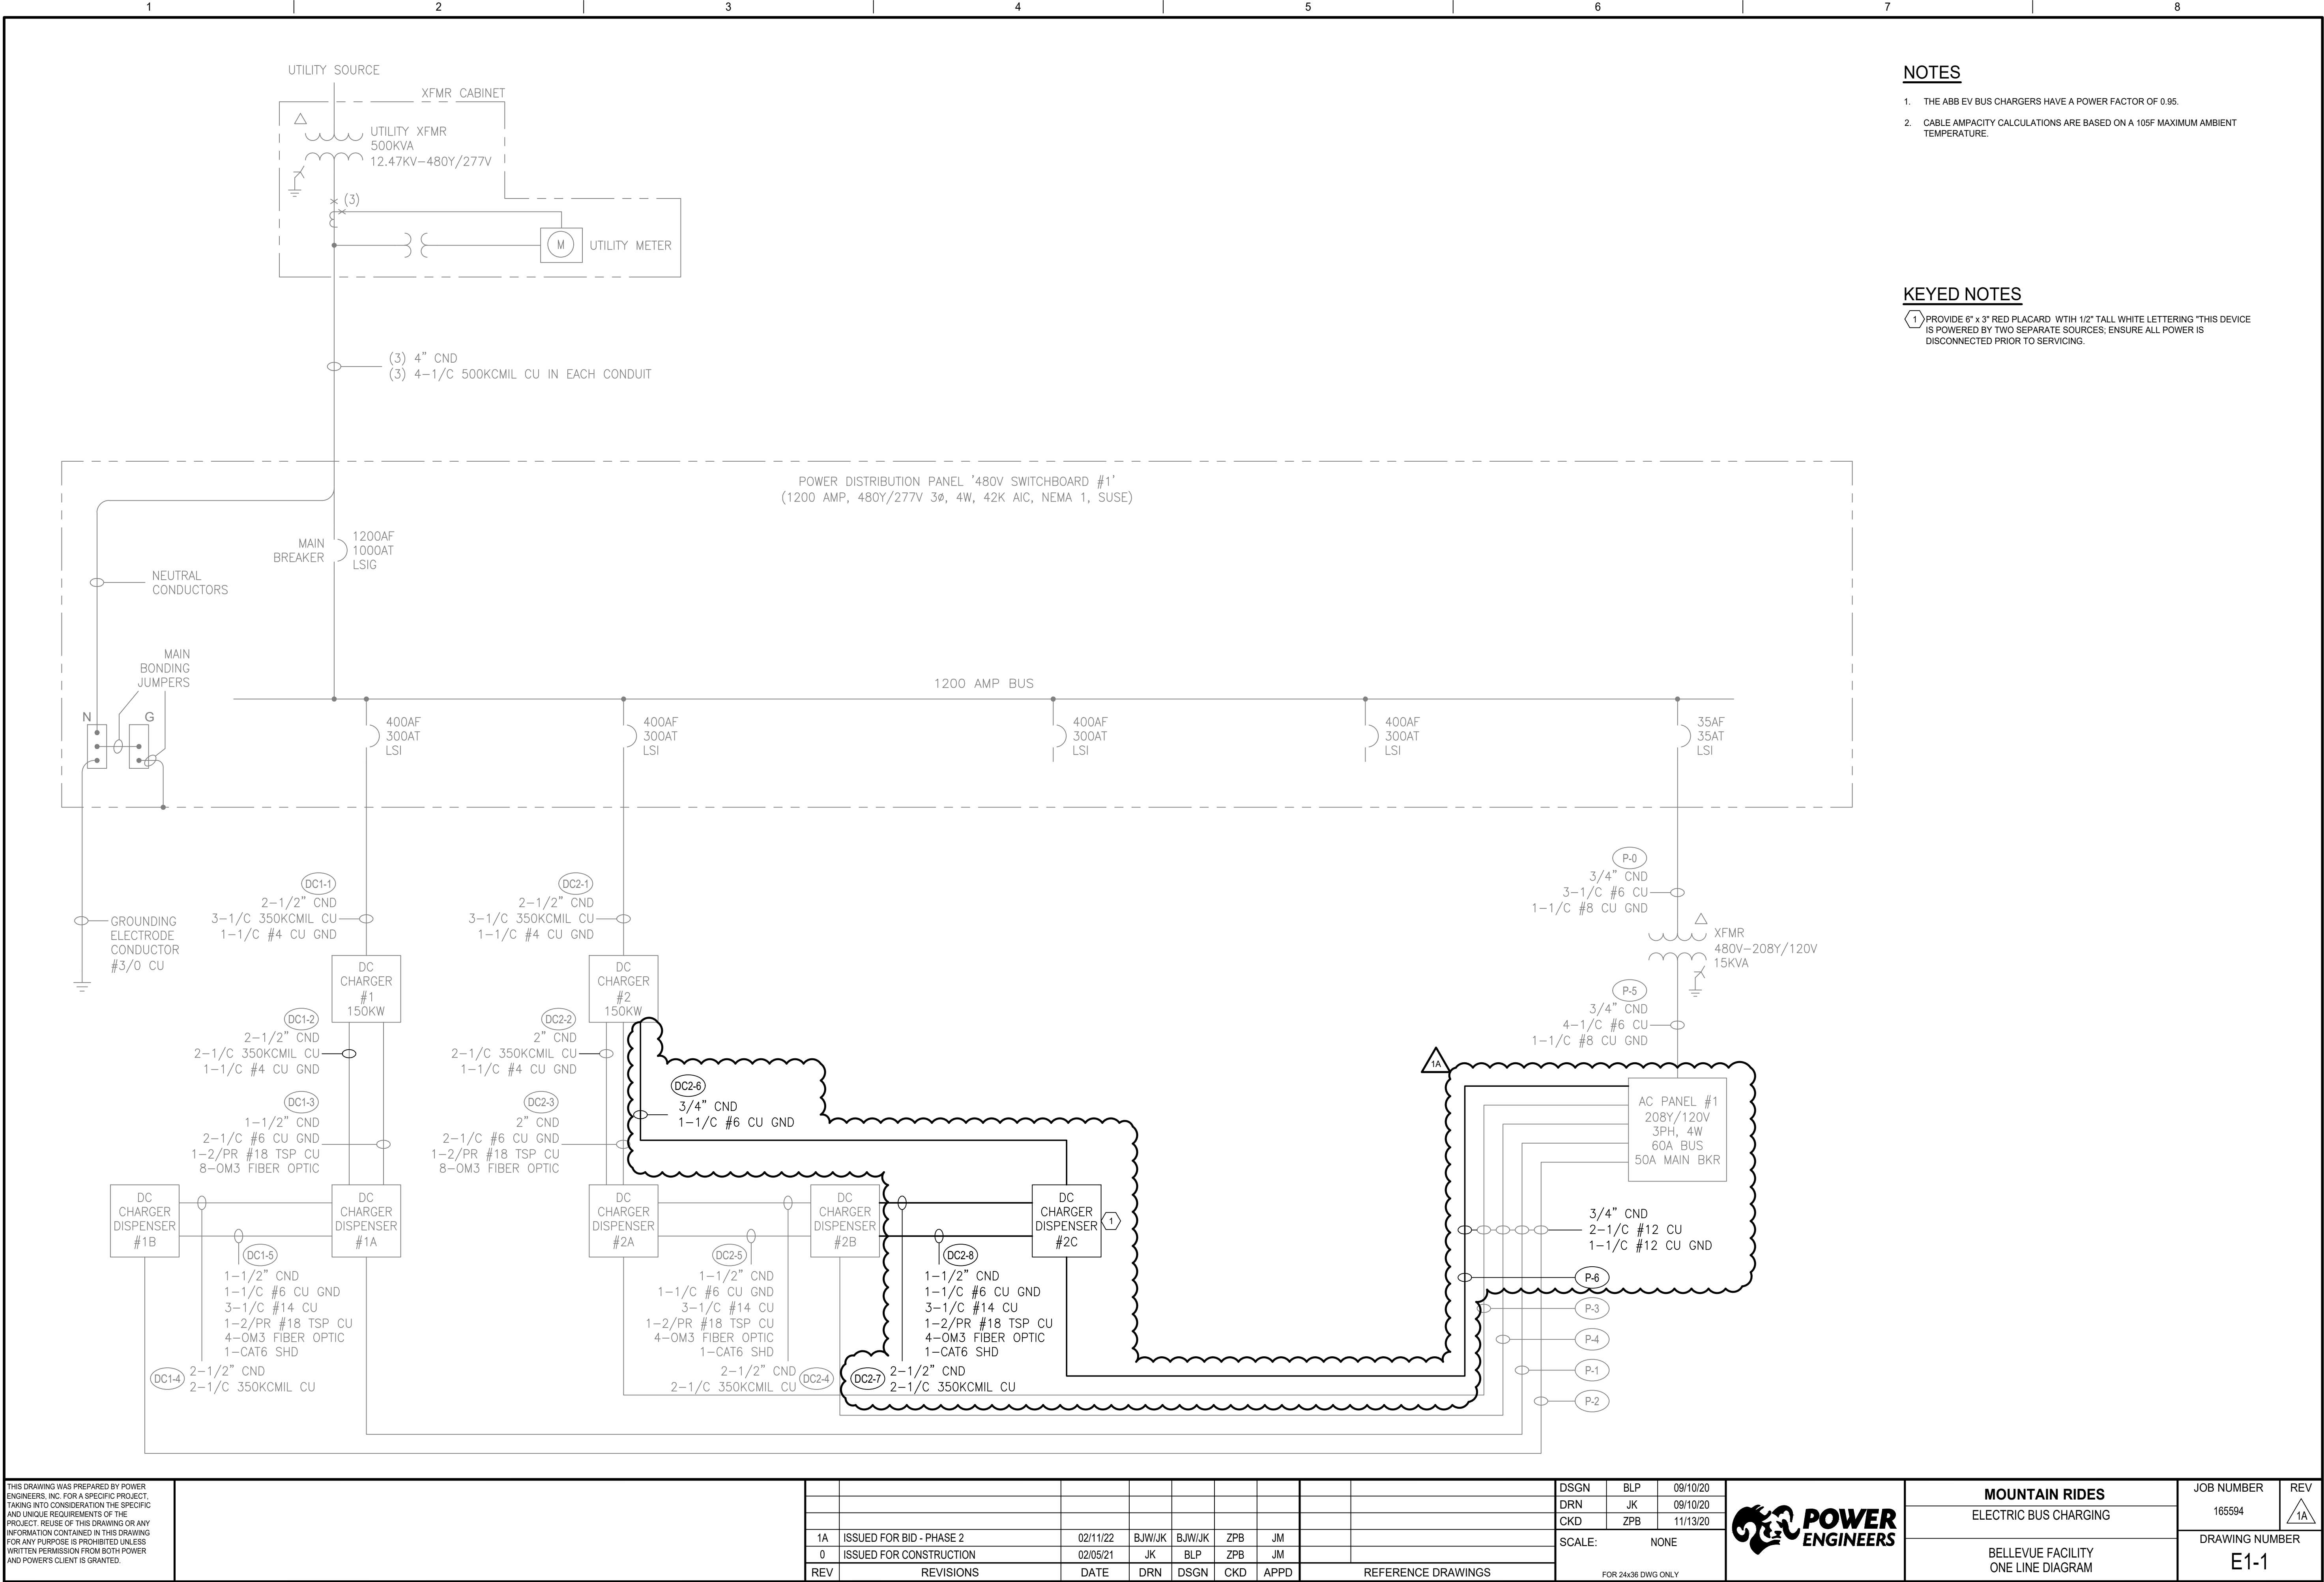


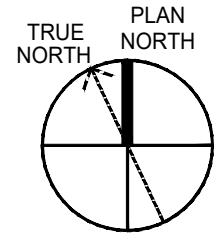

1. TWO 400A SPARE BREAKERS ON 480V SWITCHBOARD #1 ARE FOR FUTURE DC CHARGERS.

1 BREAKER SHALL COME EQUIPPED WITH A 30mA GFCI.

[illegible]

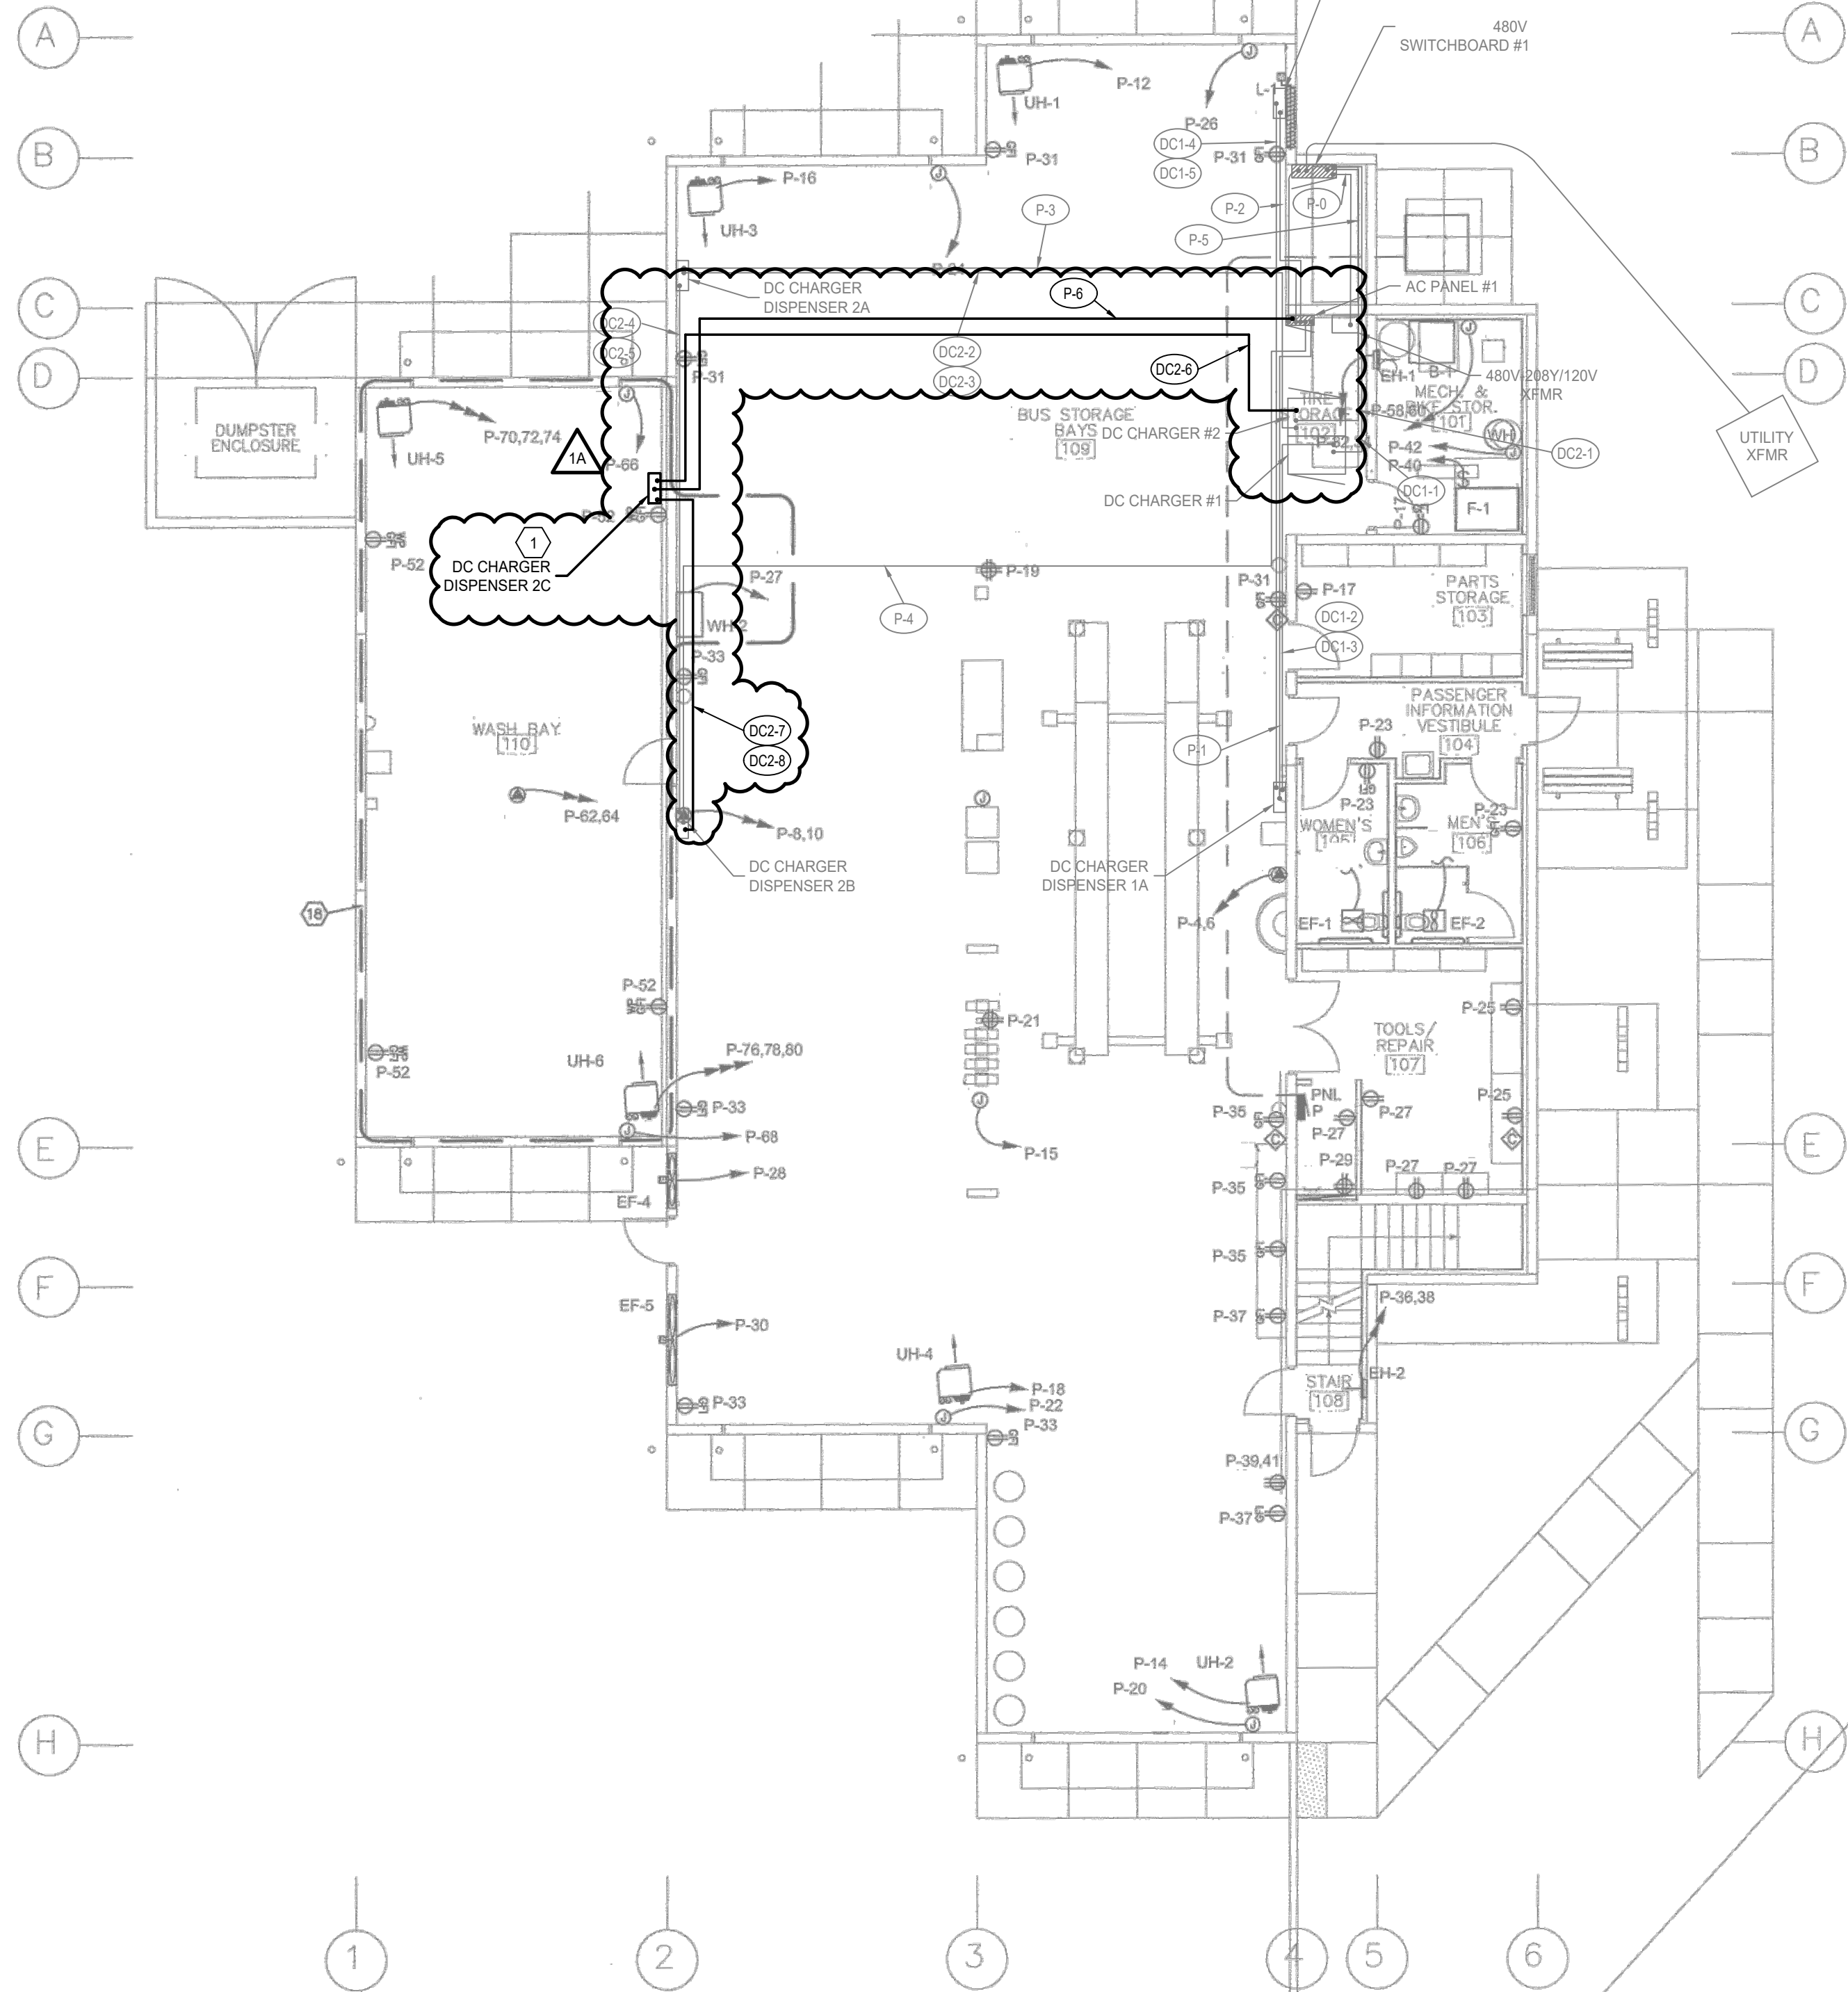

 
NOTES

- REFER TO ONE-LINE DIAGRAM DRAWING E1-1 FOR CONDUIT & CABLE REQUIREMENTS.
- CONTRACTOR TO PROVIDE EQUIPMENT, CONDUITS, & TERMINATE POWER & COMMUNICATION CABLES. REFER TO ONE LINE DIAGRAM FOR CABLE SIZING.
- CONDUIT ROUTING IS SHOWN FOR REFERENCE ONLY. CONTRACTOR TO DETERMINE THE BEST CONDUIT ROUTE IN THE FIELD.

KEYED NOTES

- 1 PROVIDE 6" x 3" RED PLACARD WITH 1/2" TALL WHITE LETTERING "THIS DEVICE IS POWERED BY TWO SEPARATE SOURCES. ENSURE ALL POWER IS DISCONNECTED PRIOR TO SERVICING."

1 FIRST FLOOR POWER PLAN
SCALE: 1/8" = 1'-0"



E7-1-BEL.DWG

THIS DRAWING WAS PREPARED BY POWER ENGINEERS, INC. FOR A SPECIFIC PROJECT, TAKING INTO CONSIDERATION THE SPECIFIC AND UNIQUE REQUIREMENTS OF THE PROJECT. REUSE OF THIS DRAWING OR ANY INFORMATION CONTAINED IN THIS DRAWING FOR ANY PURPOSE IS PROHIBITED UNLESS WRITTEN PERMISSION FROM BOTH POWER AND POWER'S CLIENT IS GRANTED.

REV	REVISIONS	DATE	DRN	DSGN	CKD	APPD	REFERENCE DRAWINGS
1A	ISSUED FOR BID - PHASE 2	02/11/22	BJW/JK	BJW/JK	ZPB	JM	
0	ISSUED FOR CONSTRUCTION	02/05/21	JK	BLP	ZPB	JM	

DSGN	BLP	09/14/20
DRN	JK	09/14/20
CKD	ZPB	11/13/20
SCALE: 1/8" = 1'-0"		
FOR 24x36 DWG ONLY		



MOUNTAIN RIDES
ELECTRIC BUS CHARGING

BELLEVUE FACILITY
FIRST FLOOR POWER PLAN

JOB NUMBER	REV
165594	1A
DRAWING NUMBER	
E7-1	